



Light plots are custom designed based upon venue capacity and hall size. Sponsor shall advance venue specifics with Artist's Lighting Director, Michele Preshaw, M: +61 417 545 649, Empreshaw@netspace.net.au

The following provided as examples only and may be used for reference only...

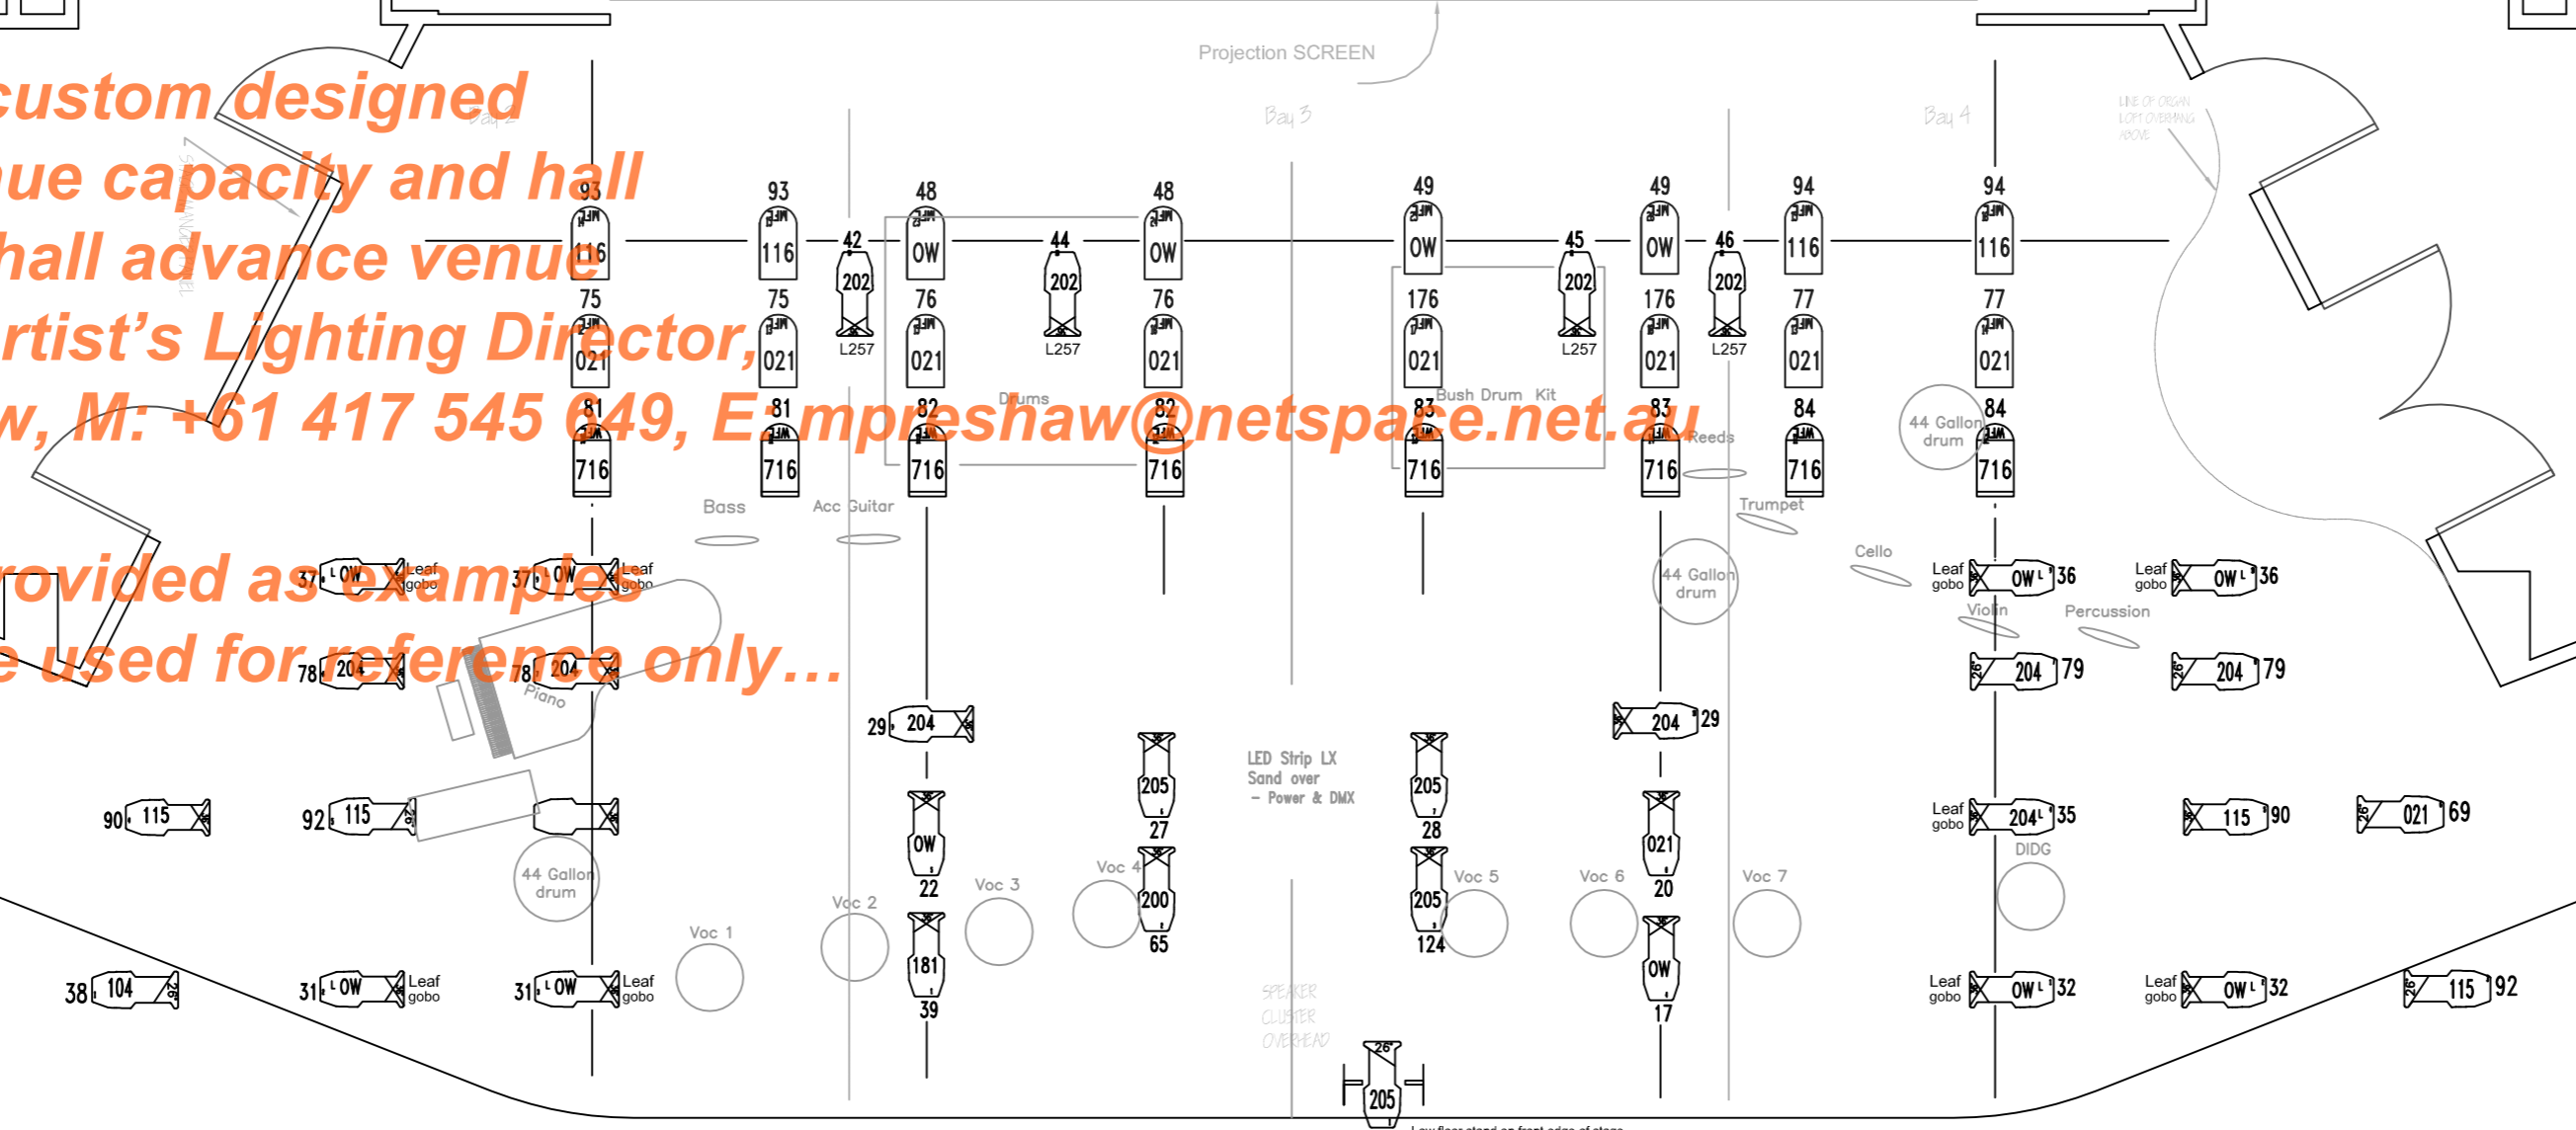

SPAULDING AUDITORIUM HOPKINS CENTRE

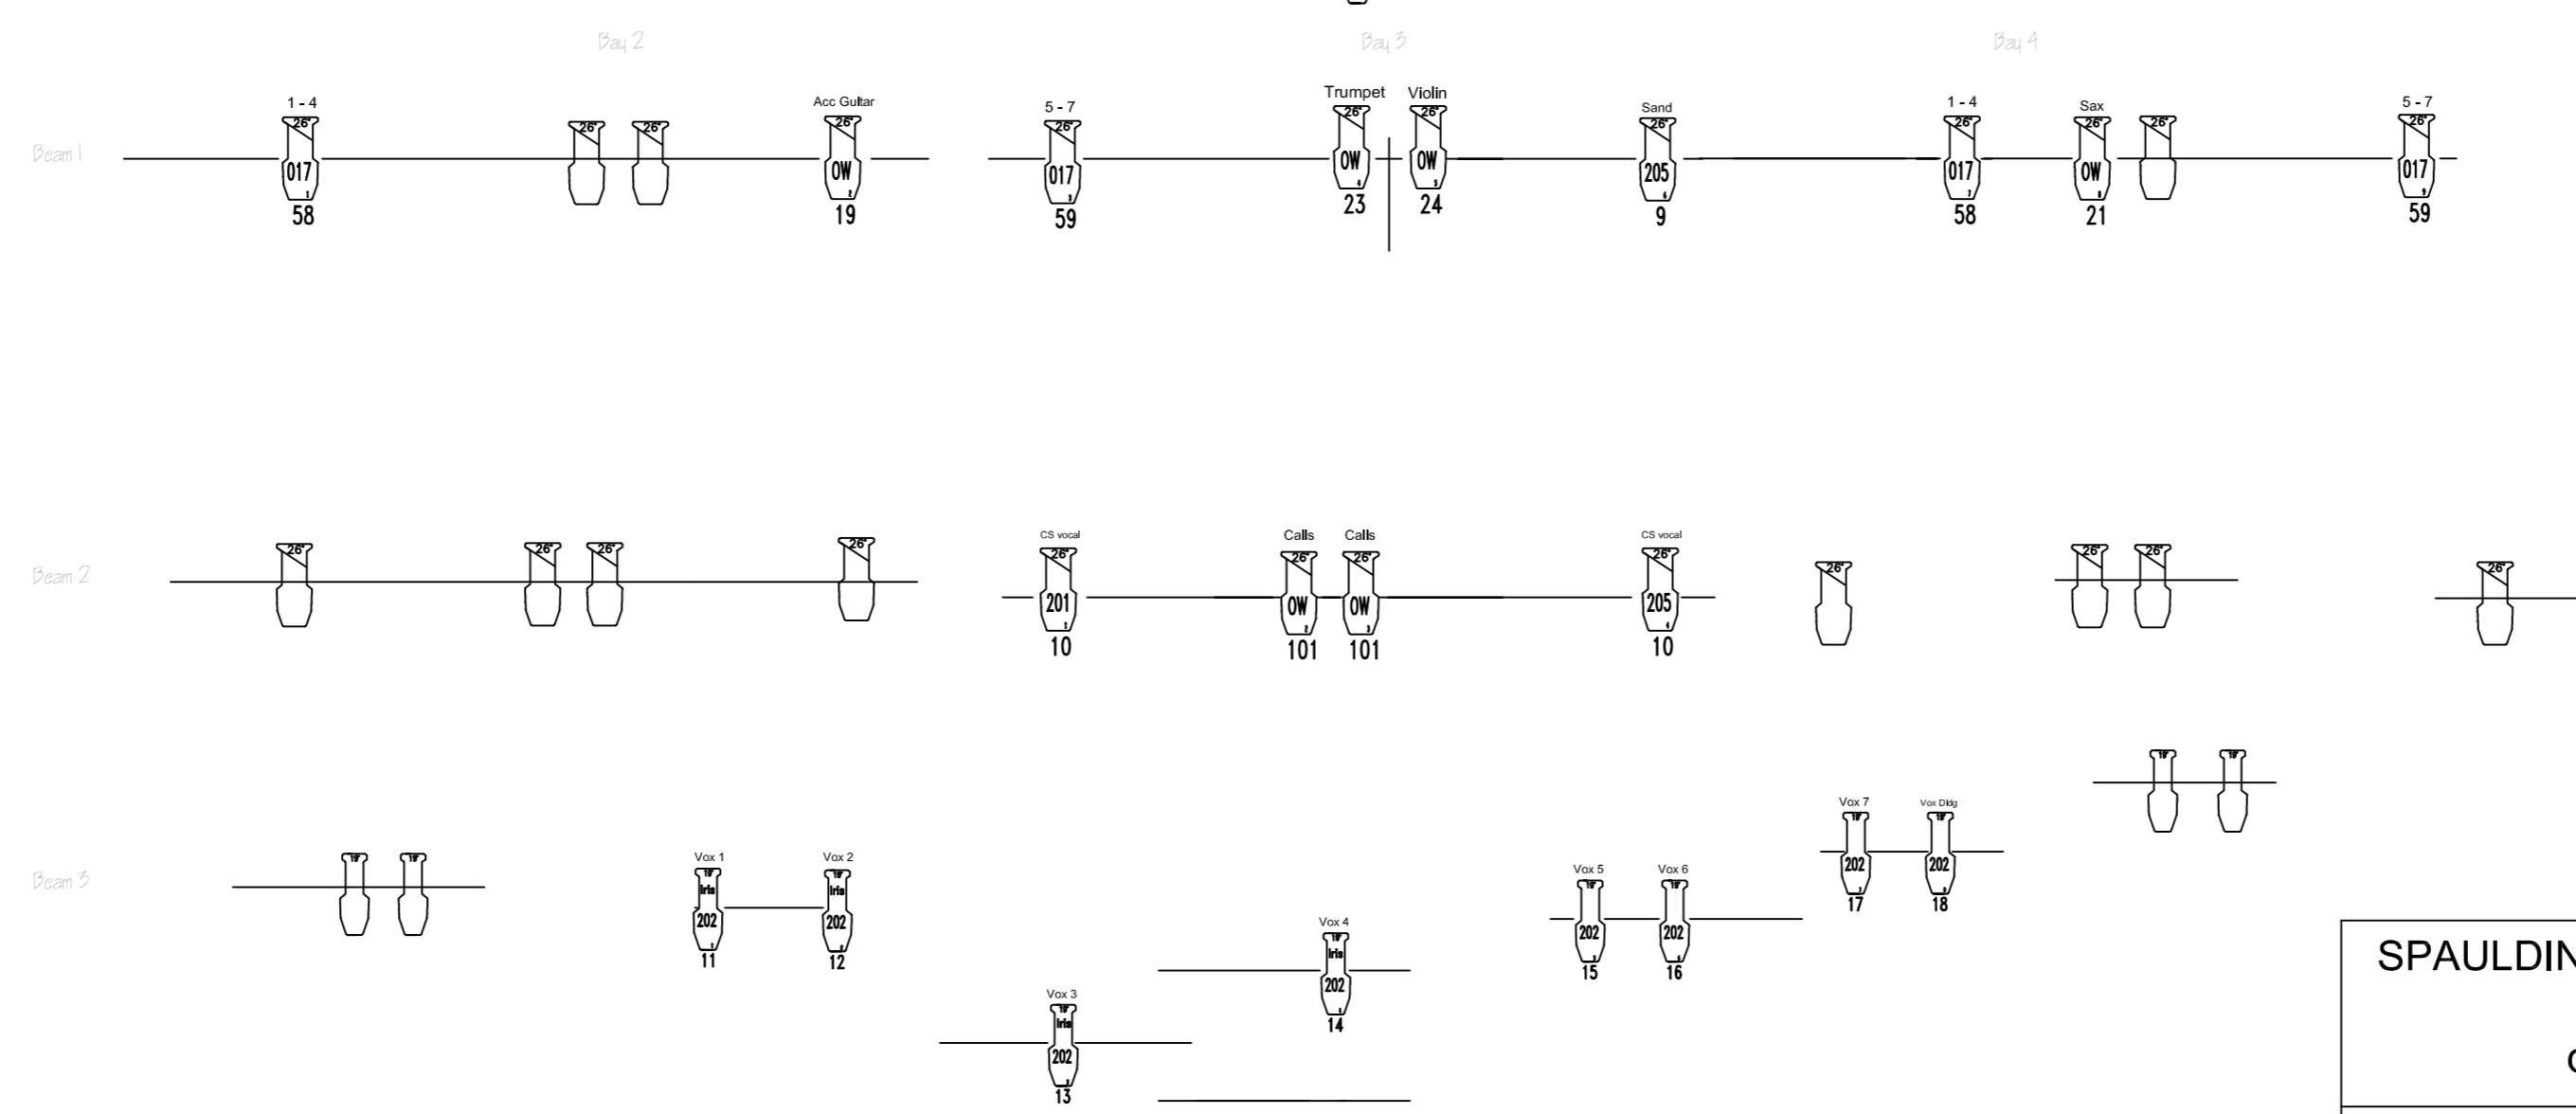

LEGEND & NOTES:

- Source 4 19
- Source 4 26
- Source 4 36
- PAR 64 WIDE
- PAR 64 MEDIUM
- Low floor stand

KEY:

- FOCUS
- INSTRUMENT TYPE
- DROP-IN IRIS
- COLOUR
- GOBO
- INSTRUMENT NUMBER
- CHANNEL

Standard Rig has been used
 Only lanterns with channel information are used
 6 x variable iris are required FOH
 All colour is LEE Filter
 Gobos are LEE Medium Leaf Breakup (or similar)
 CH 25 can be any low profile/small lantern

SPAULDING AUDITORIUM, HOPKINS CENTRE

dirtsong, Black Arm Band

Lighting Plan	DATE:	SCALE: 1/4" = 1'-0"
DRAWN BY: M. Preshaw		

9L5AD@.-\$\$!GYUhiJYbi Y